



SCALE IN FEET 1/4"

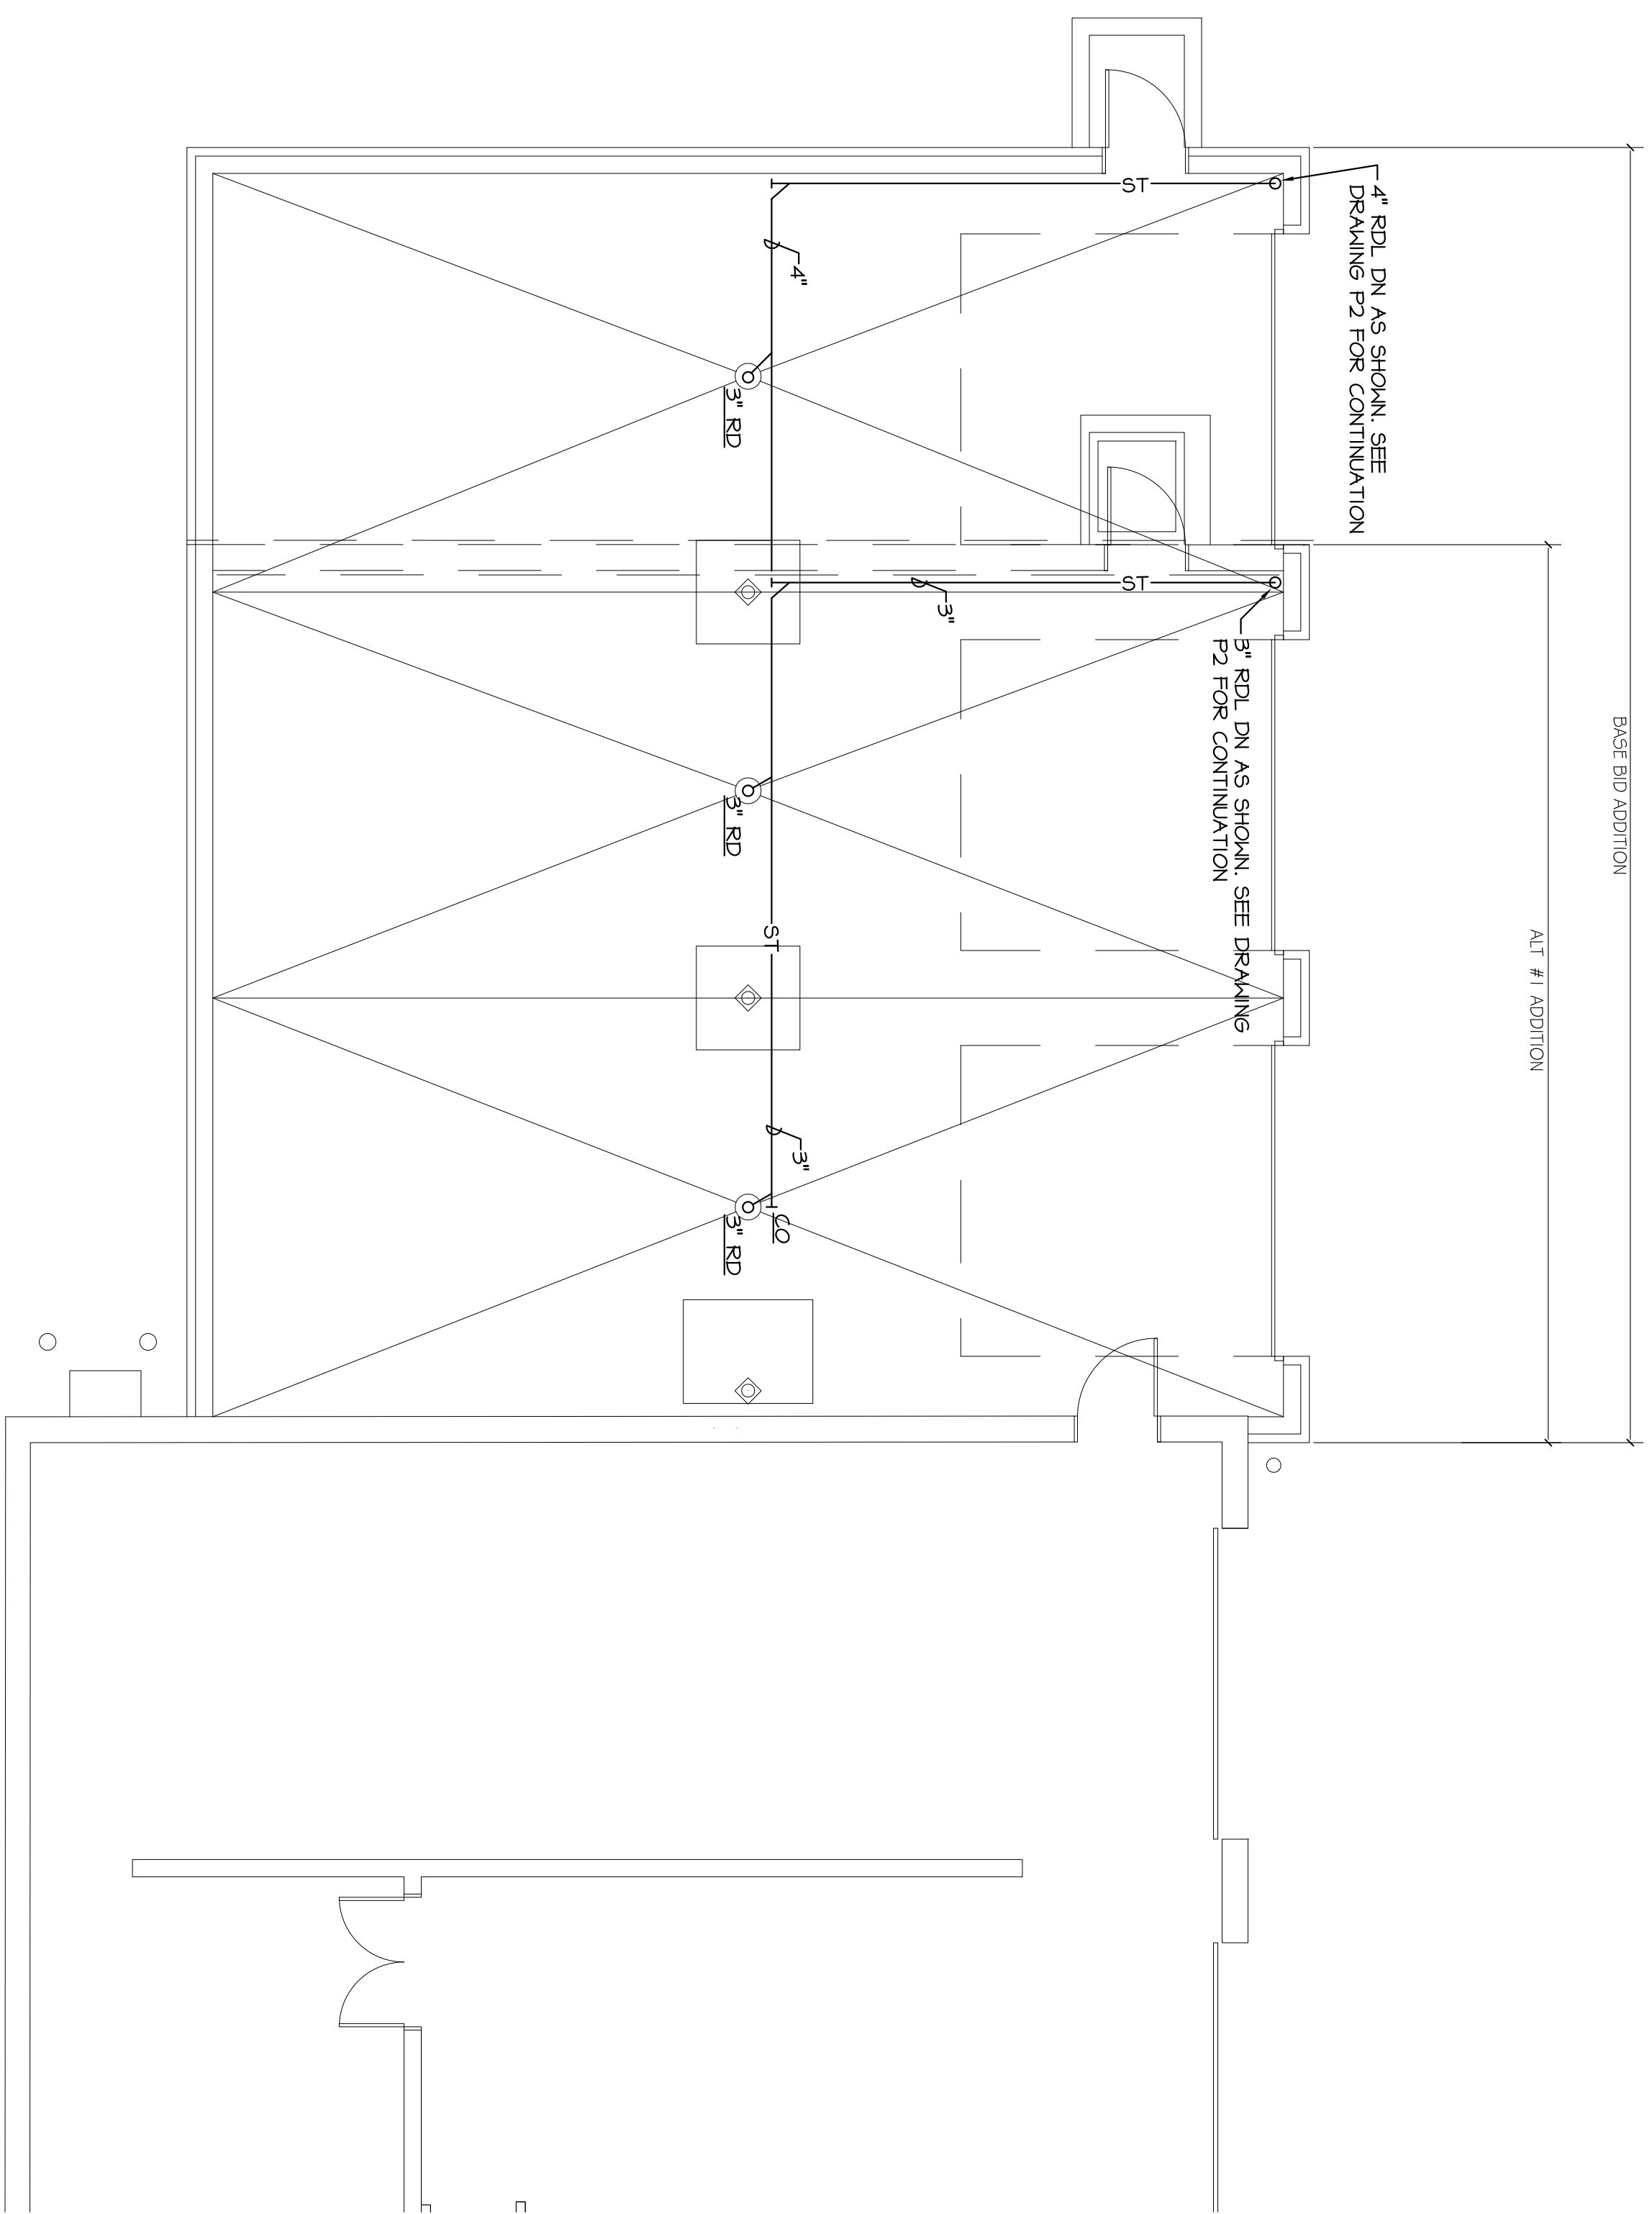

ROOF PLAN - PLUMBING
SCALE: 3/16"=1'-0"

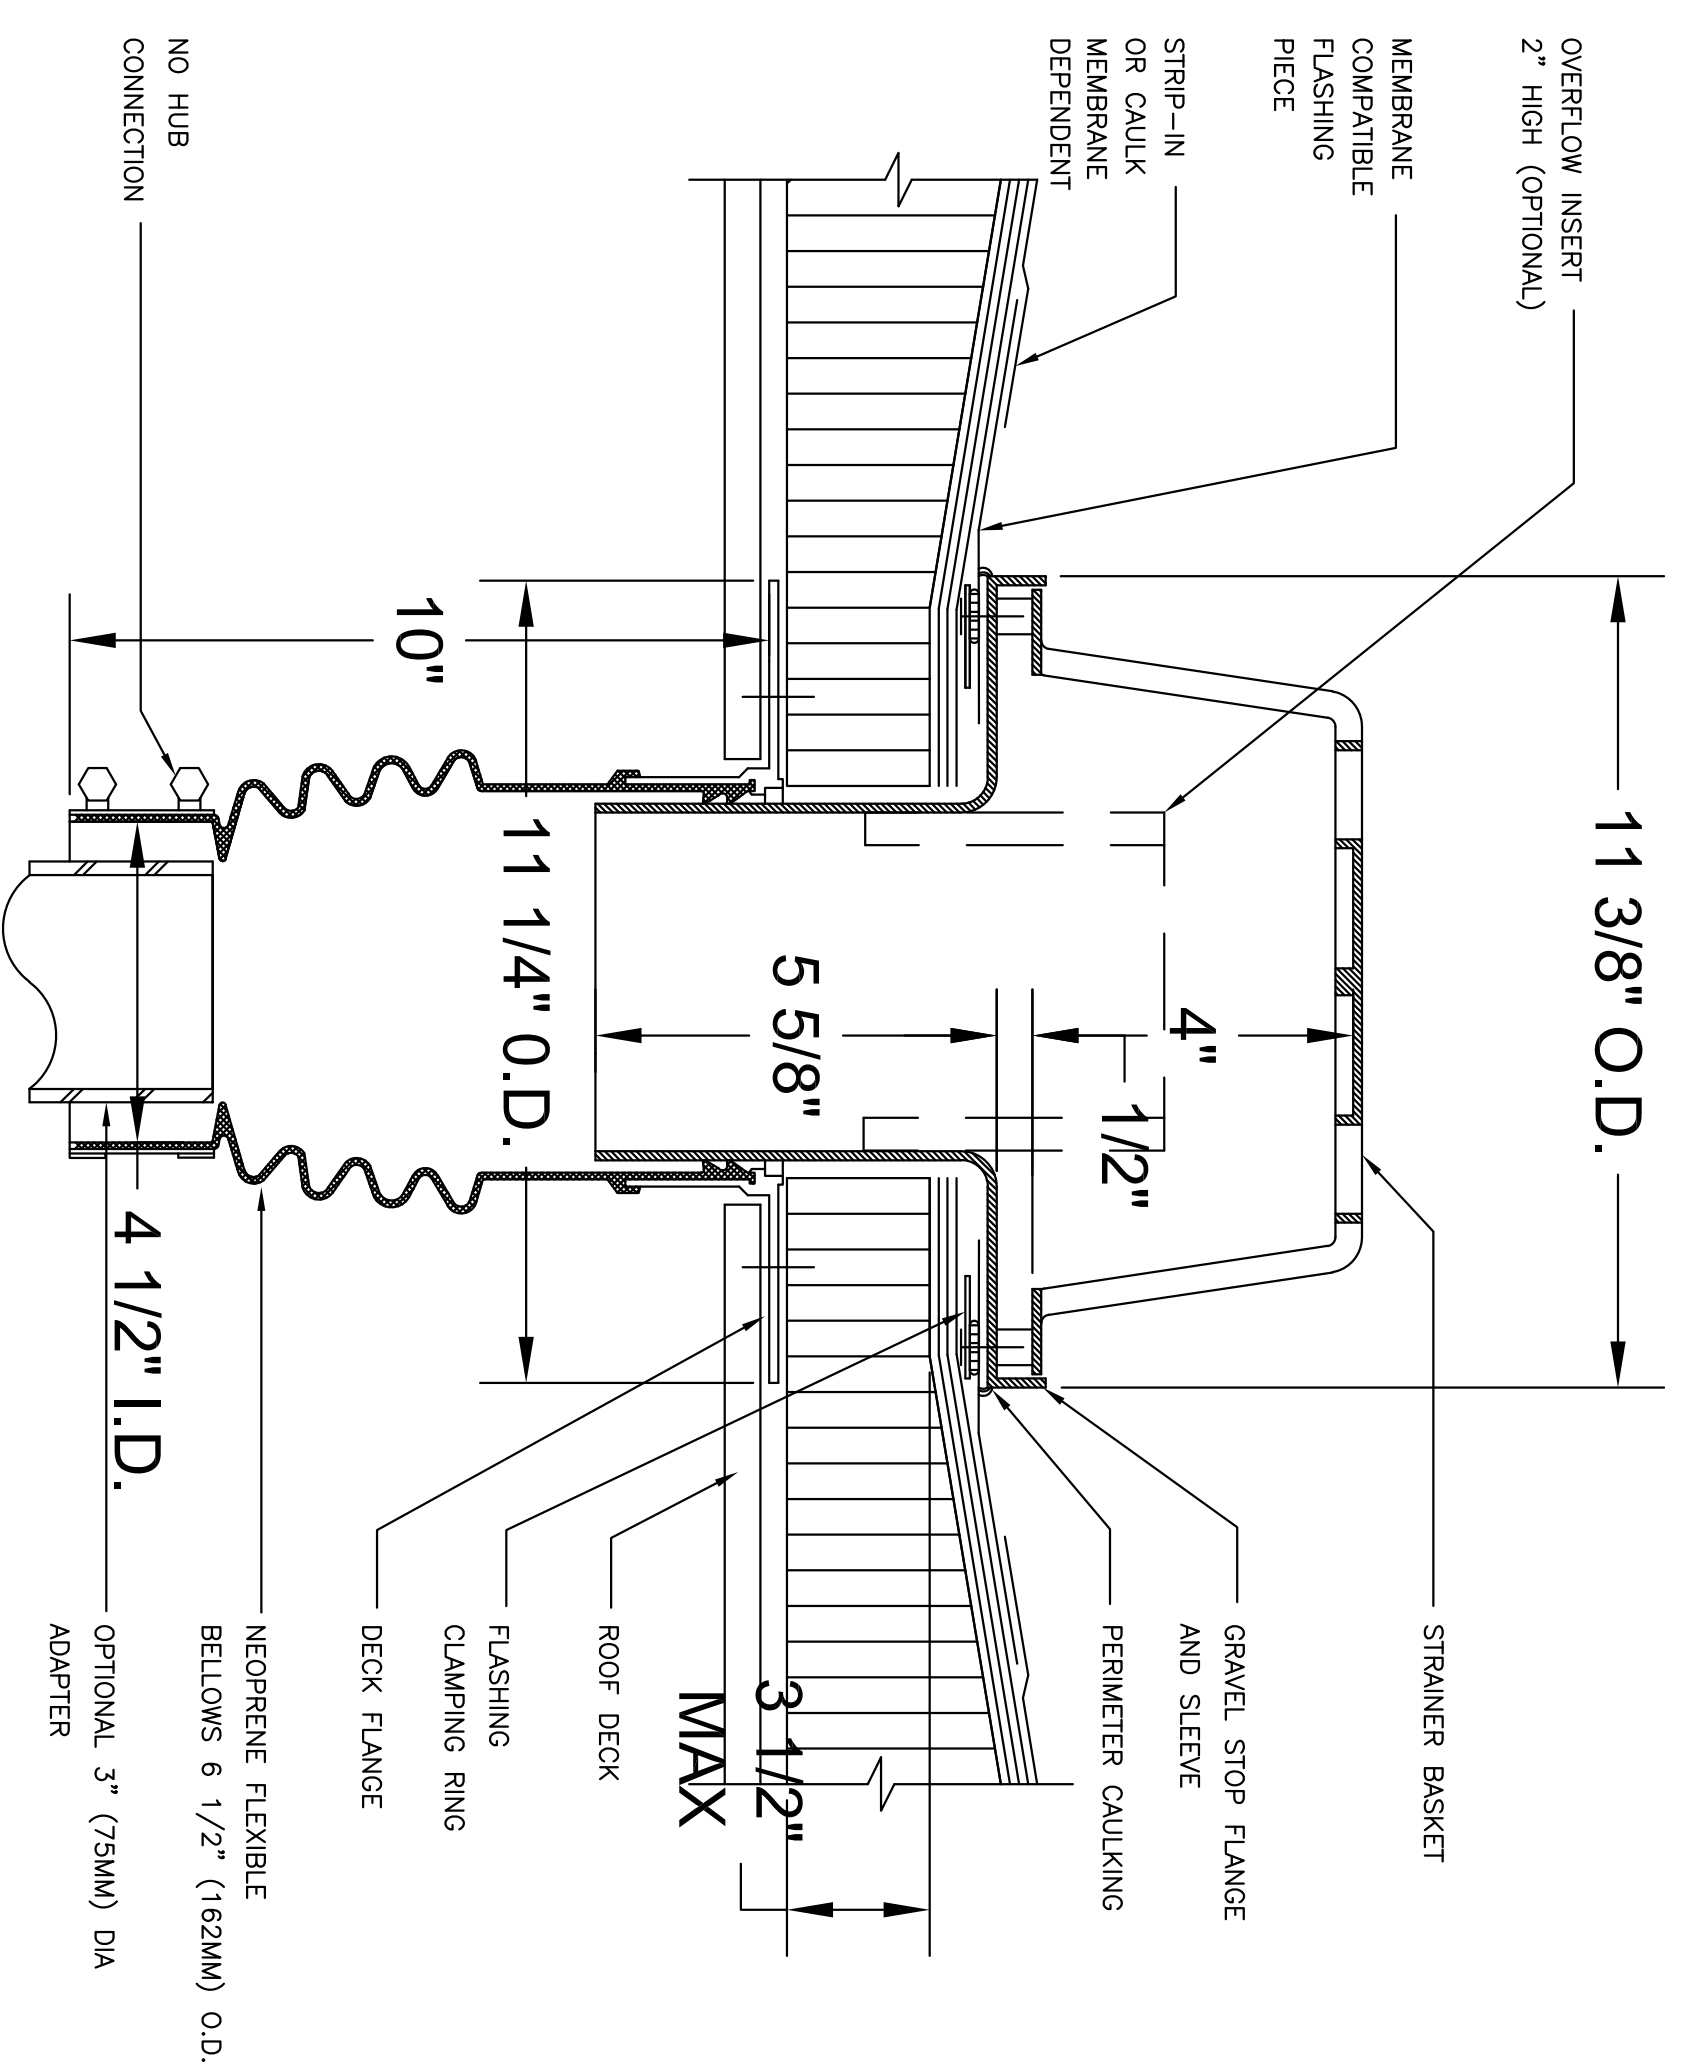


ROOF DRAIN DETAIL
N.T.S.

J.M. VEROSTKO, INC.
CONSULTING ENGINEERS
2781 SALT SPRINGS ROAD
YOUNGSTOWN, OHIO 44509
PHONE: (330) 799-1339
URL: J.M.VEROSTKO.COM

NEWPORT LIBRARY GARAGE ADDITION

NEWPORT BRANCH LIBRARY

YOUNGSTOWN, OHIO

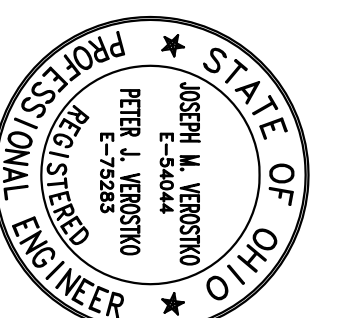

FANIRO ARCHITECTS, INC.

217 1/2 WEST FEDERAL STREET YOUNGSTOWN, OHIO 44503

PHONE: 330 747 2800

FACSIMILE: 330 747 2802

SHEET NO. **P-3** DATE 30 SEPT. 2019

PROJ. NO. 1913 REV.

