



THE INFORMATION CONTAINED ON THIS DRAWING WAS ORIGINATED BY RONALD CORNELL FANIRO ARCHITECT INC. REPRODUCTION OR USE OF THIS DRAWING IS PERMITTED ONLY BY WRITTEN CONSENT OF THE ARCHITECT.

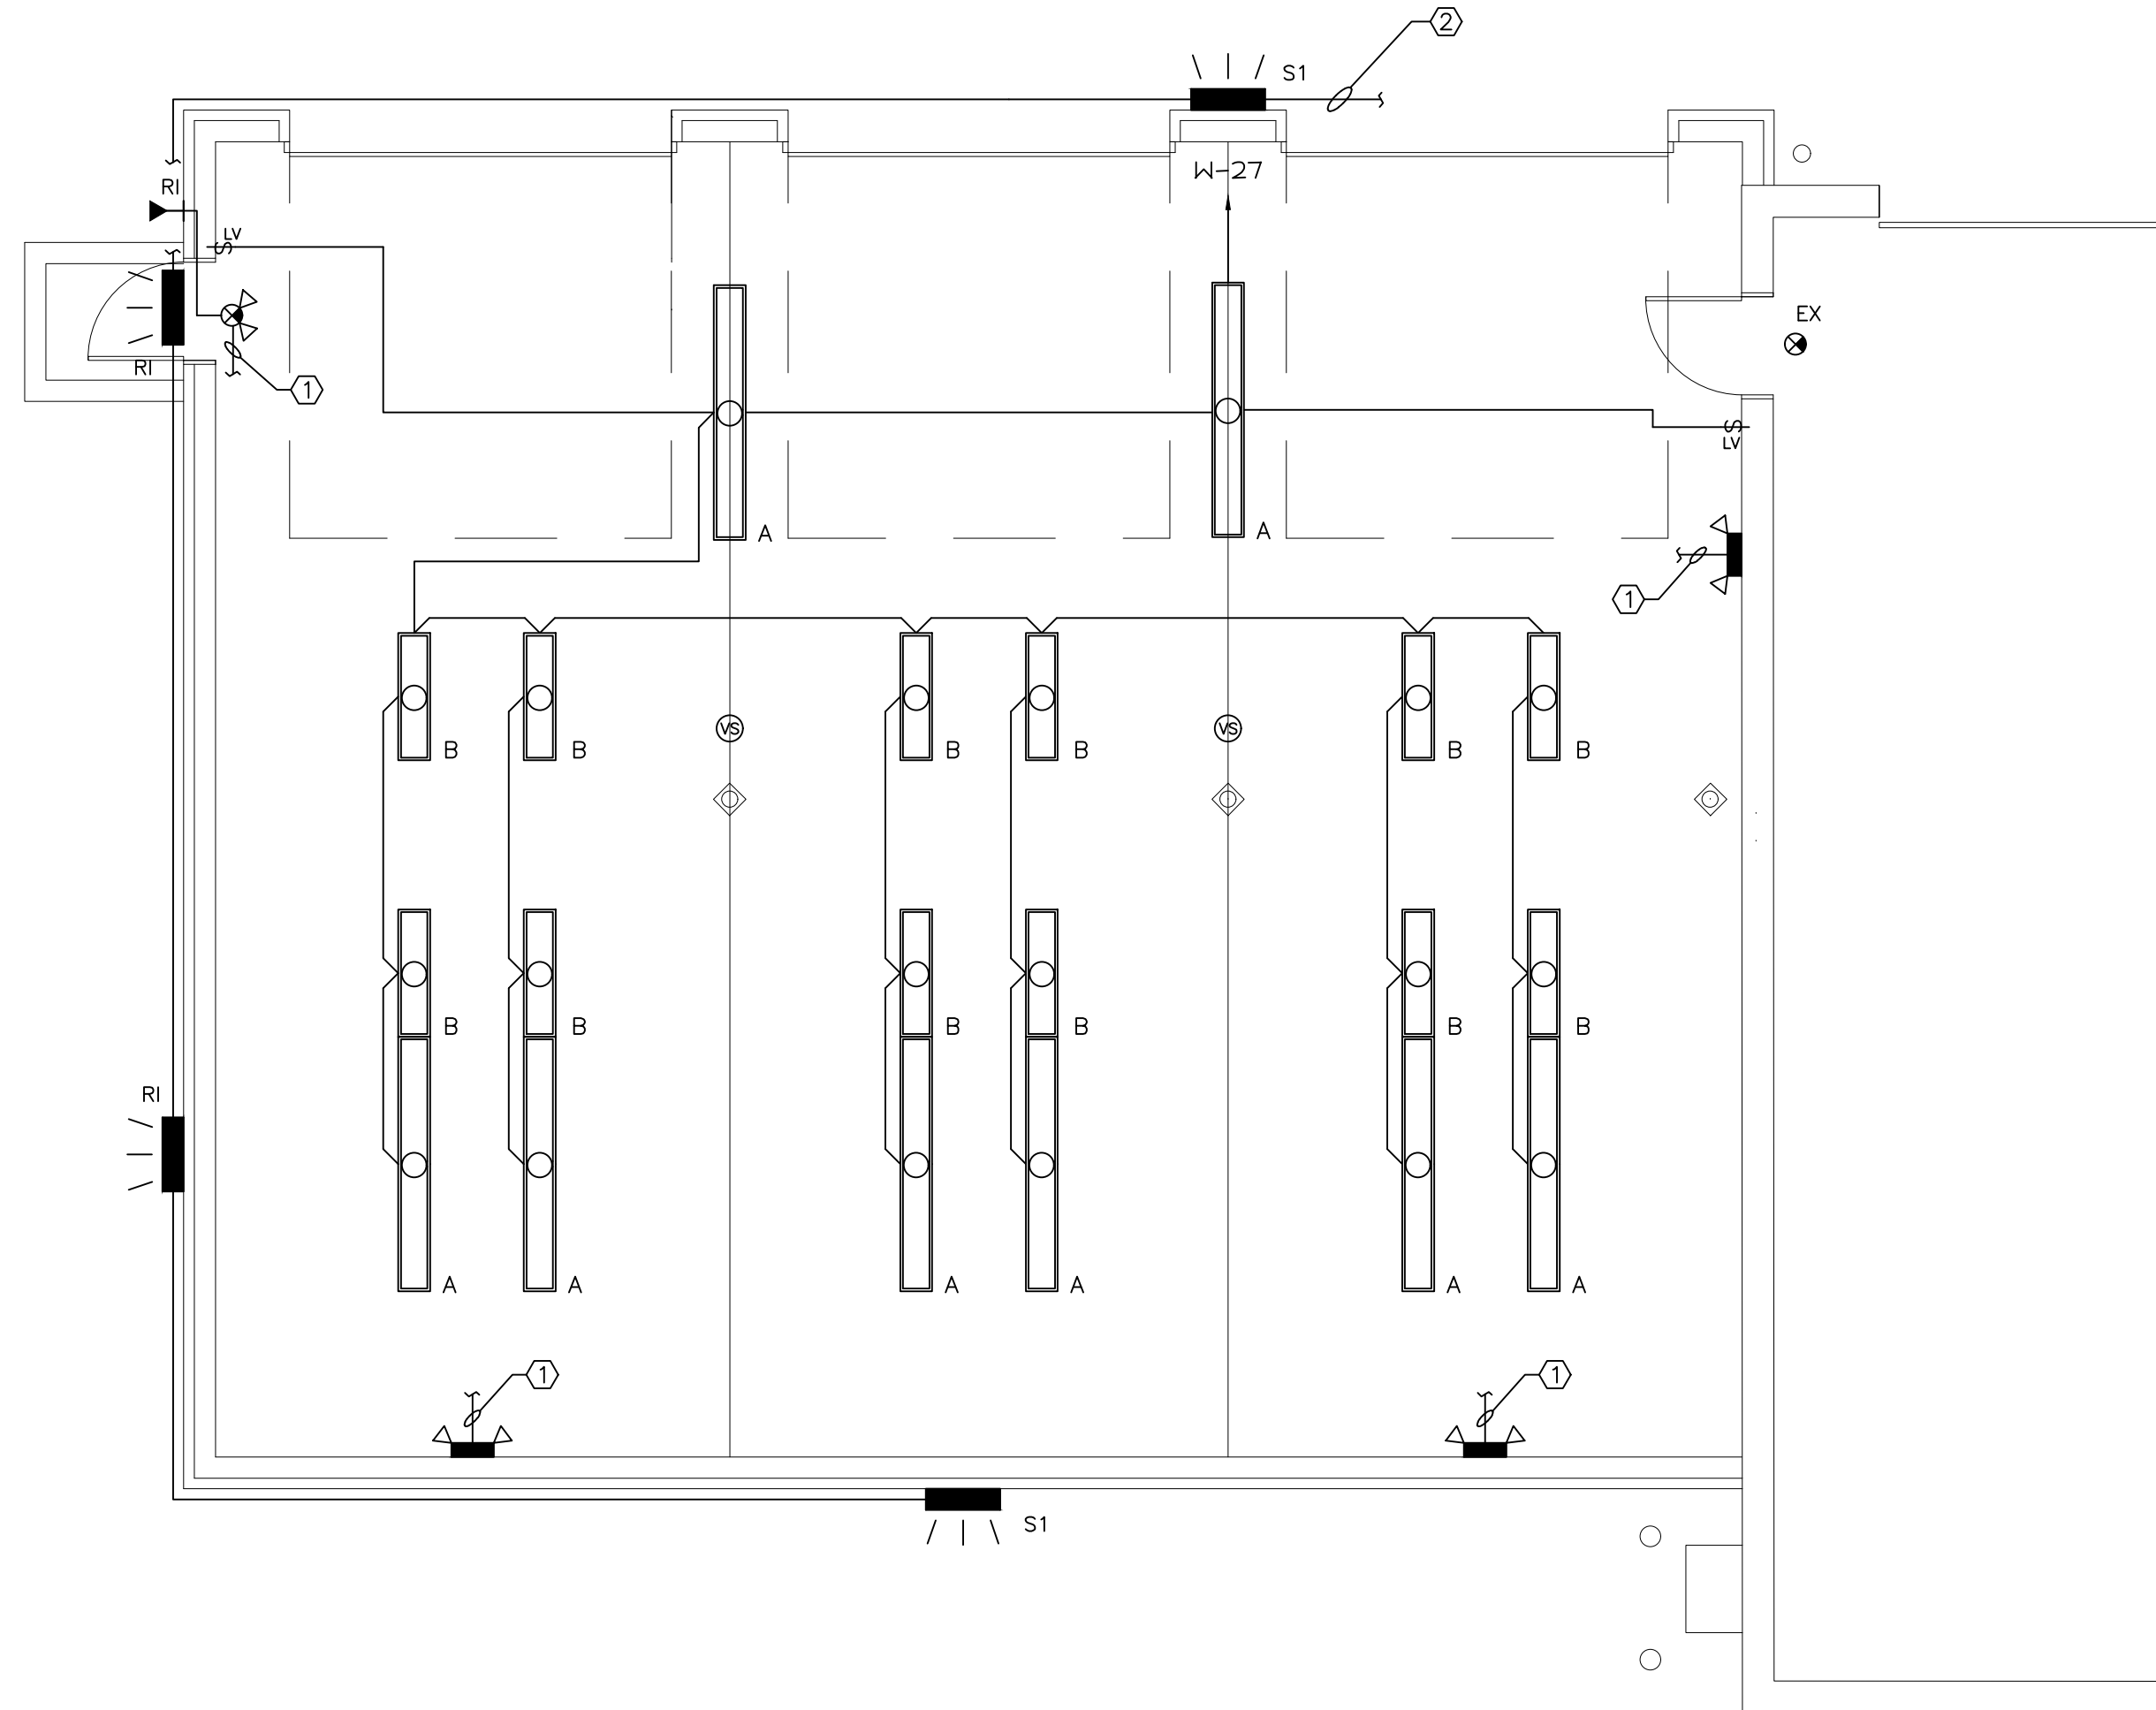


**FLOOR PLAN - LIGHTING - BASE BID ADDITION**  
SCALE: 3/16"=1'-0"

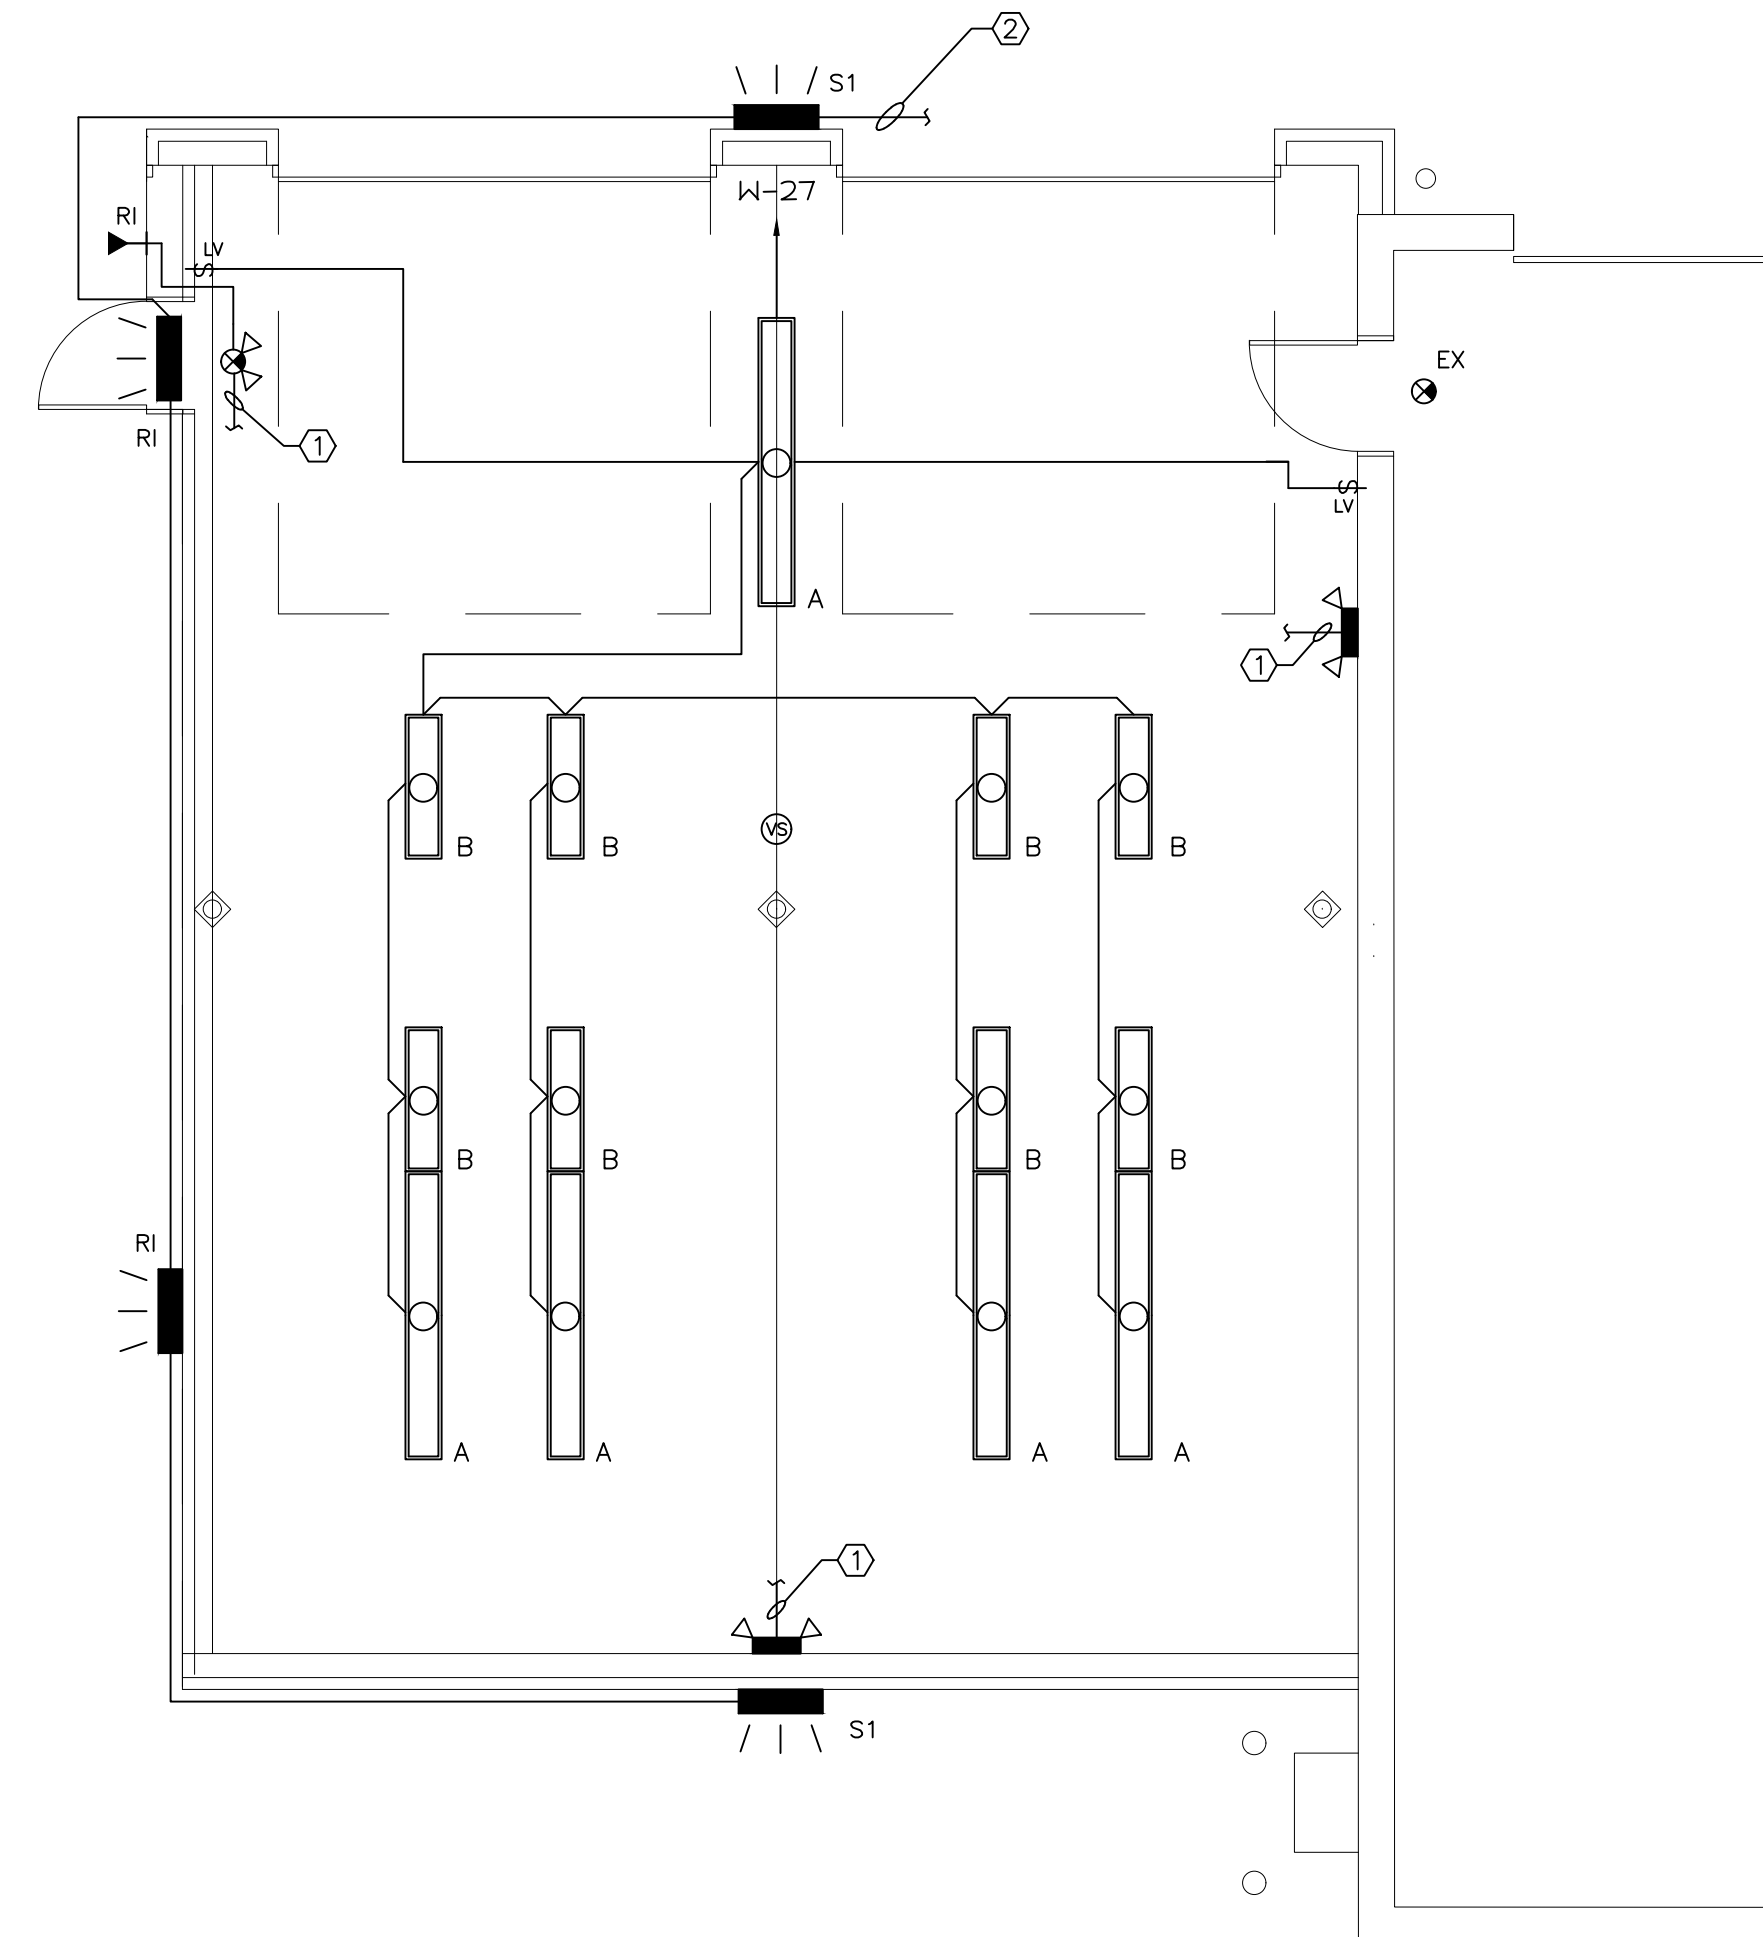

**FLOOR PLAN - LIGHTING - ALT #1 ADDITION**  
SCALE: 3/16"=1'-0"

**NOTES**

- ① CONNECT TO ROOM LIGHTING CIRCUIT AHEAD OF ALL SWITCHING AND/OR CONTROL.
- ② RECONNECT TO EXISTING EXTERIOR LIGHTING CIRCUIT AND CONTROL.

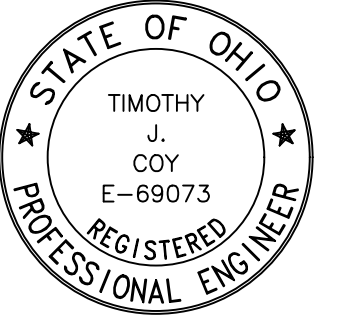

**NEWPORT LIBRARY GARAGE ADDITION**

YOUNGSTOWN, OHIO

NEWPORT BRANCH LIBRARY

**FANIRO ARCHITECTS, INC.**

217 1/2 WEST FEDERAL STREET YOUNGSTOWN, OHIO 44503

PHONE: 330 747 2800  
FACSIMILE: 330 747 2802

SHEET NO. **E-2** DATE 30 SEPT. 2019

PROJ. NO. 1913 REV.

