




THE INFORMATION CONTAINED ON THIS DRAWING WAS ORIGINATED BY RONALD CORNELL FANIRO ARCHITECT INC. REPRODUCTION OR USE OF THIS DRAWING IS PERMITTED ONLY BY WRITTEN CONSENT OF THE ARCHITECT.

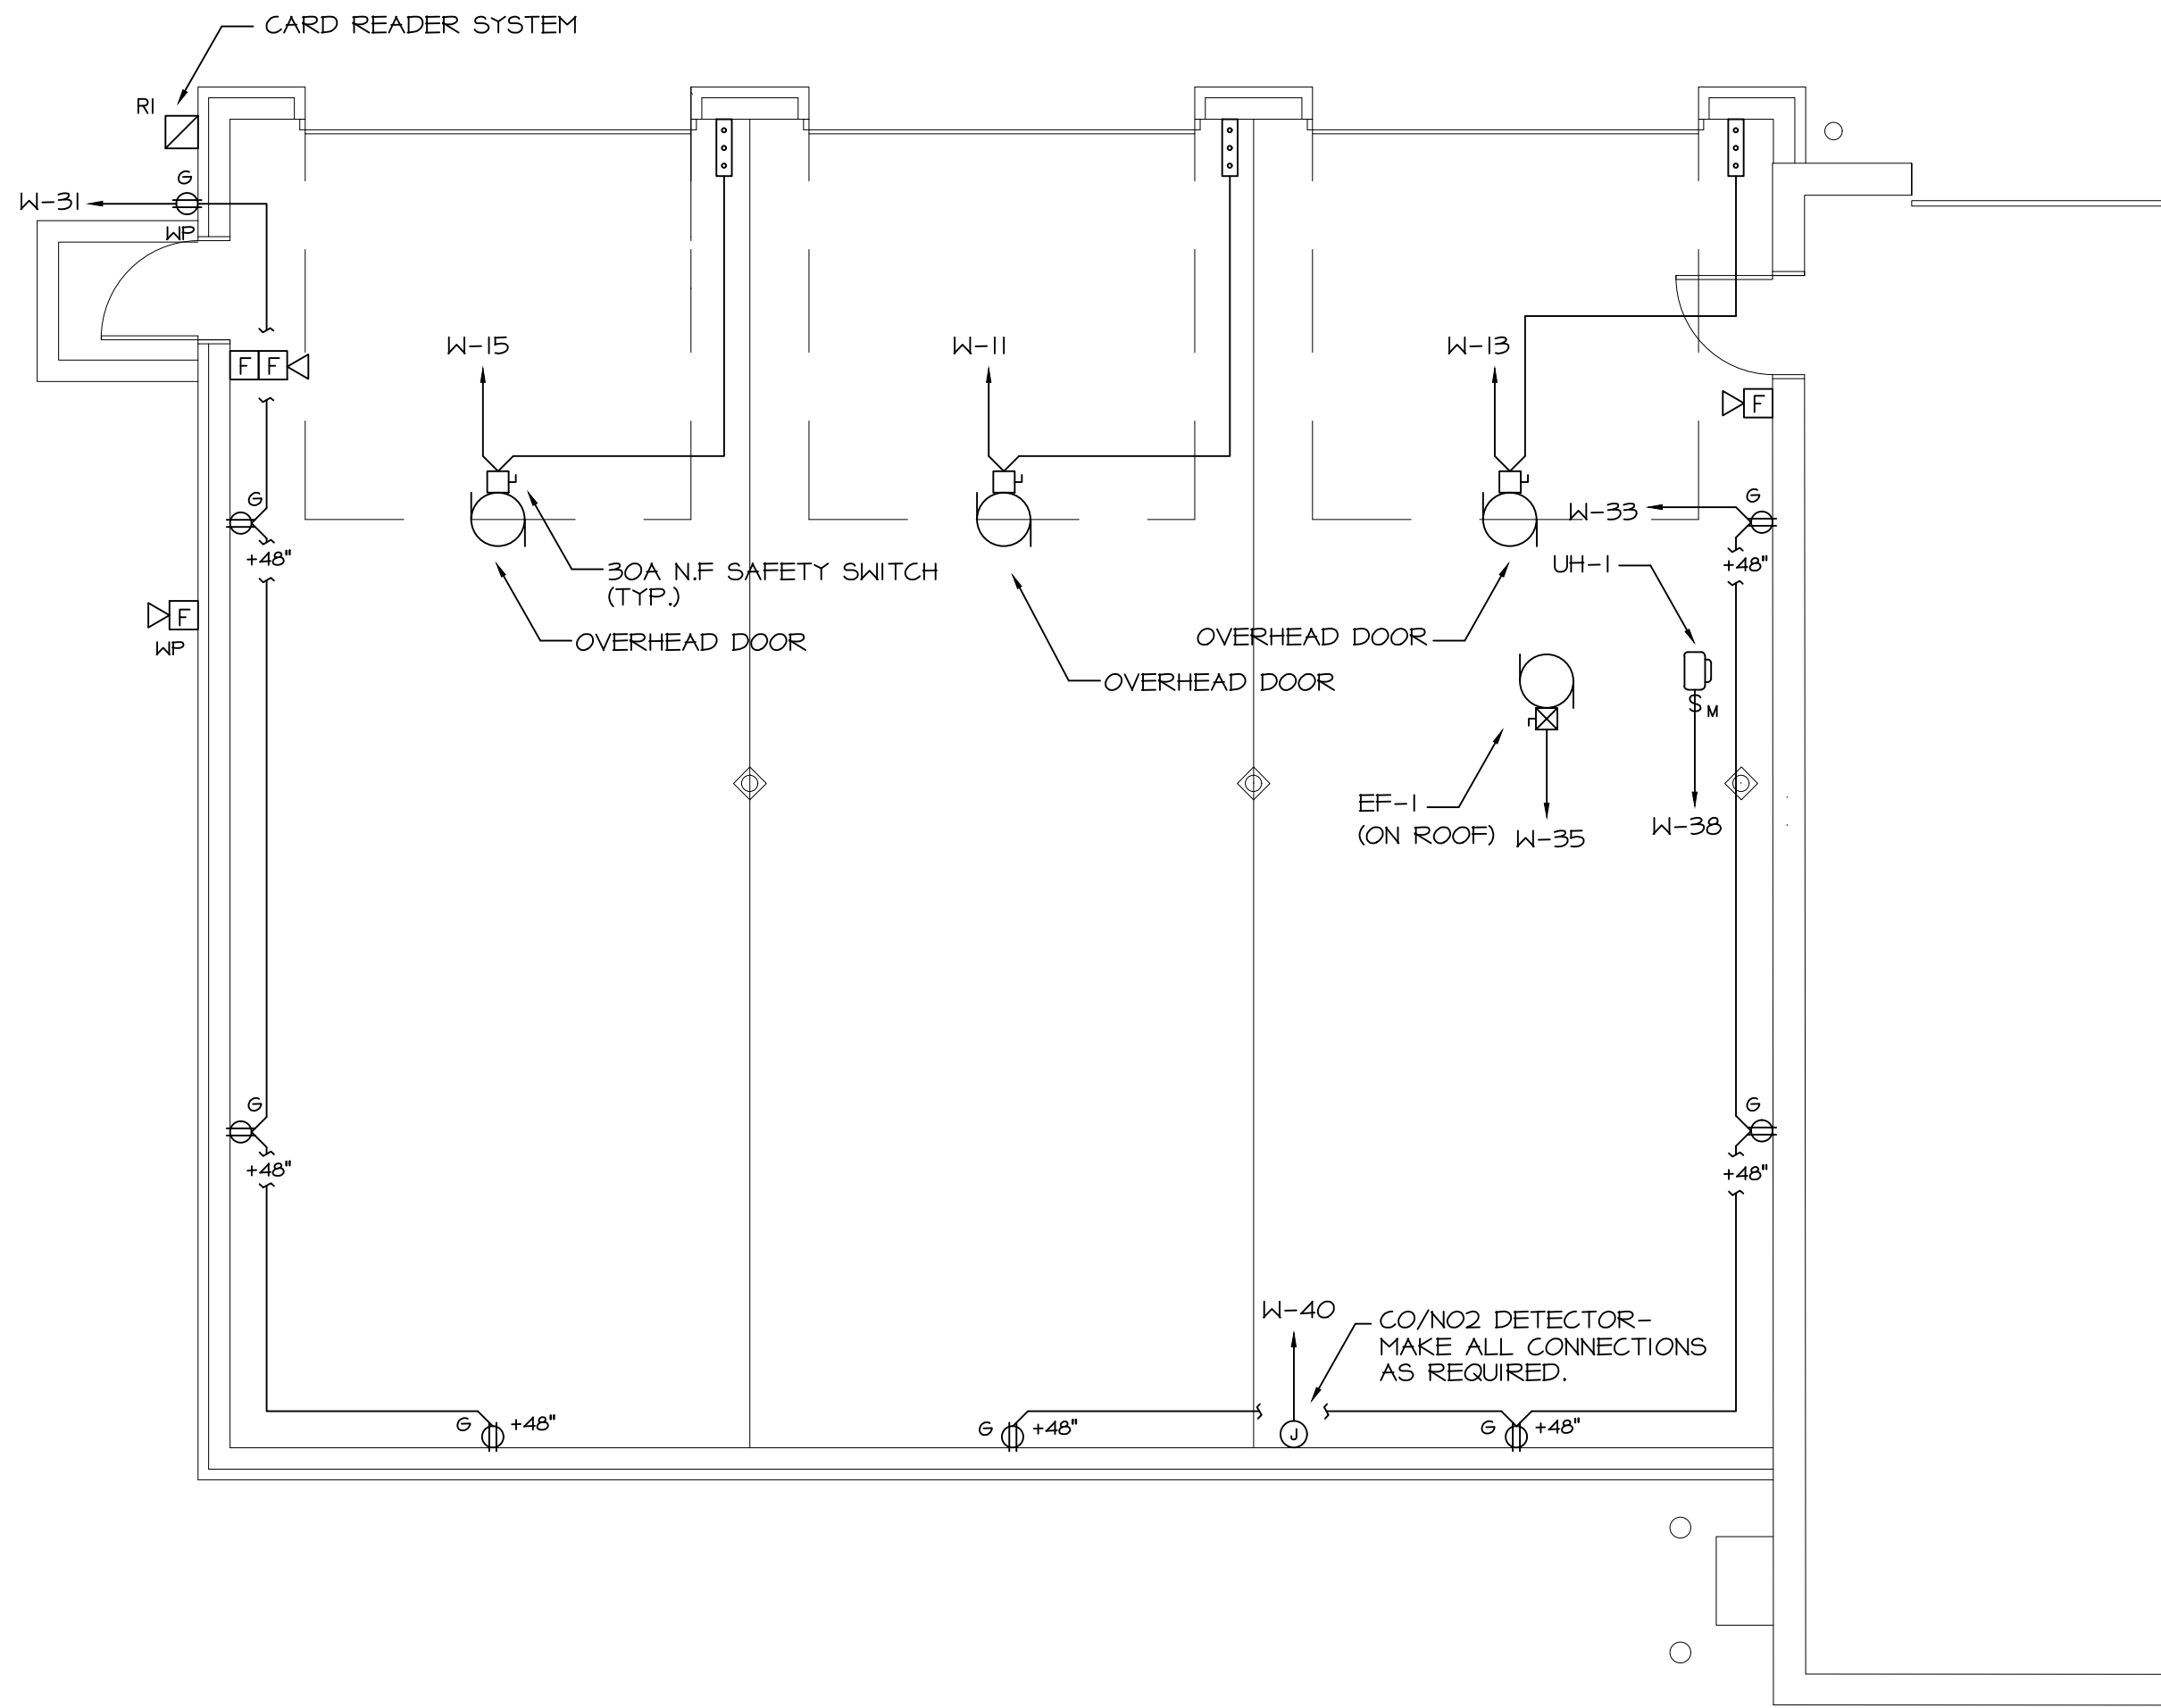

**FLOOR PLAN - POWER AND SYSTEMS BASE BID ADDITION**  
 SCALE: 3/16"=1'-0"

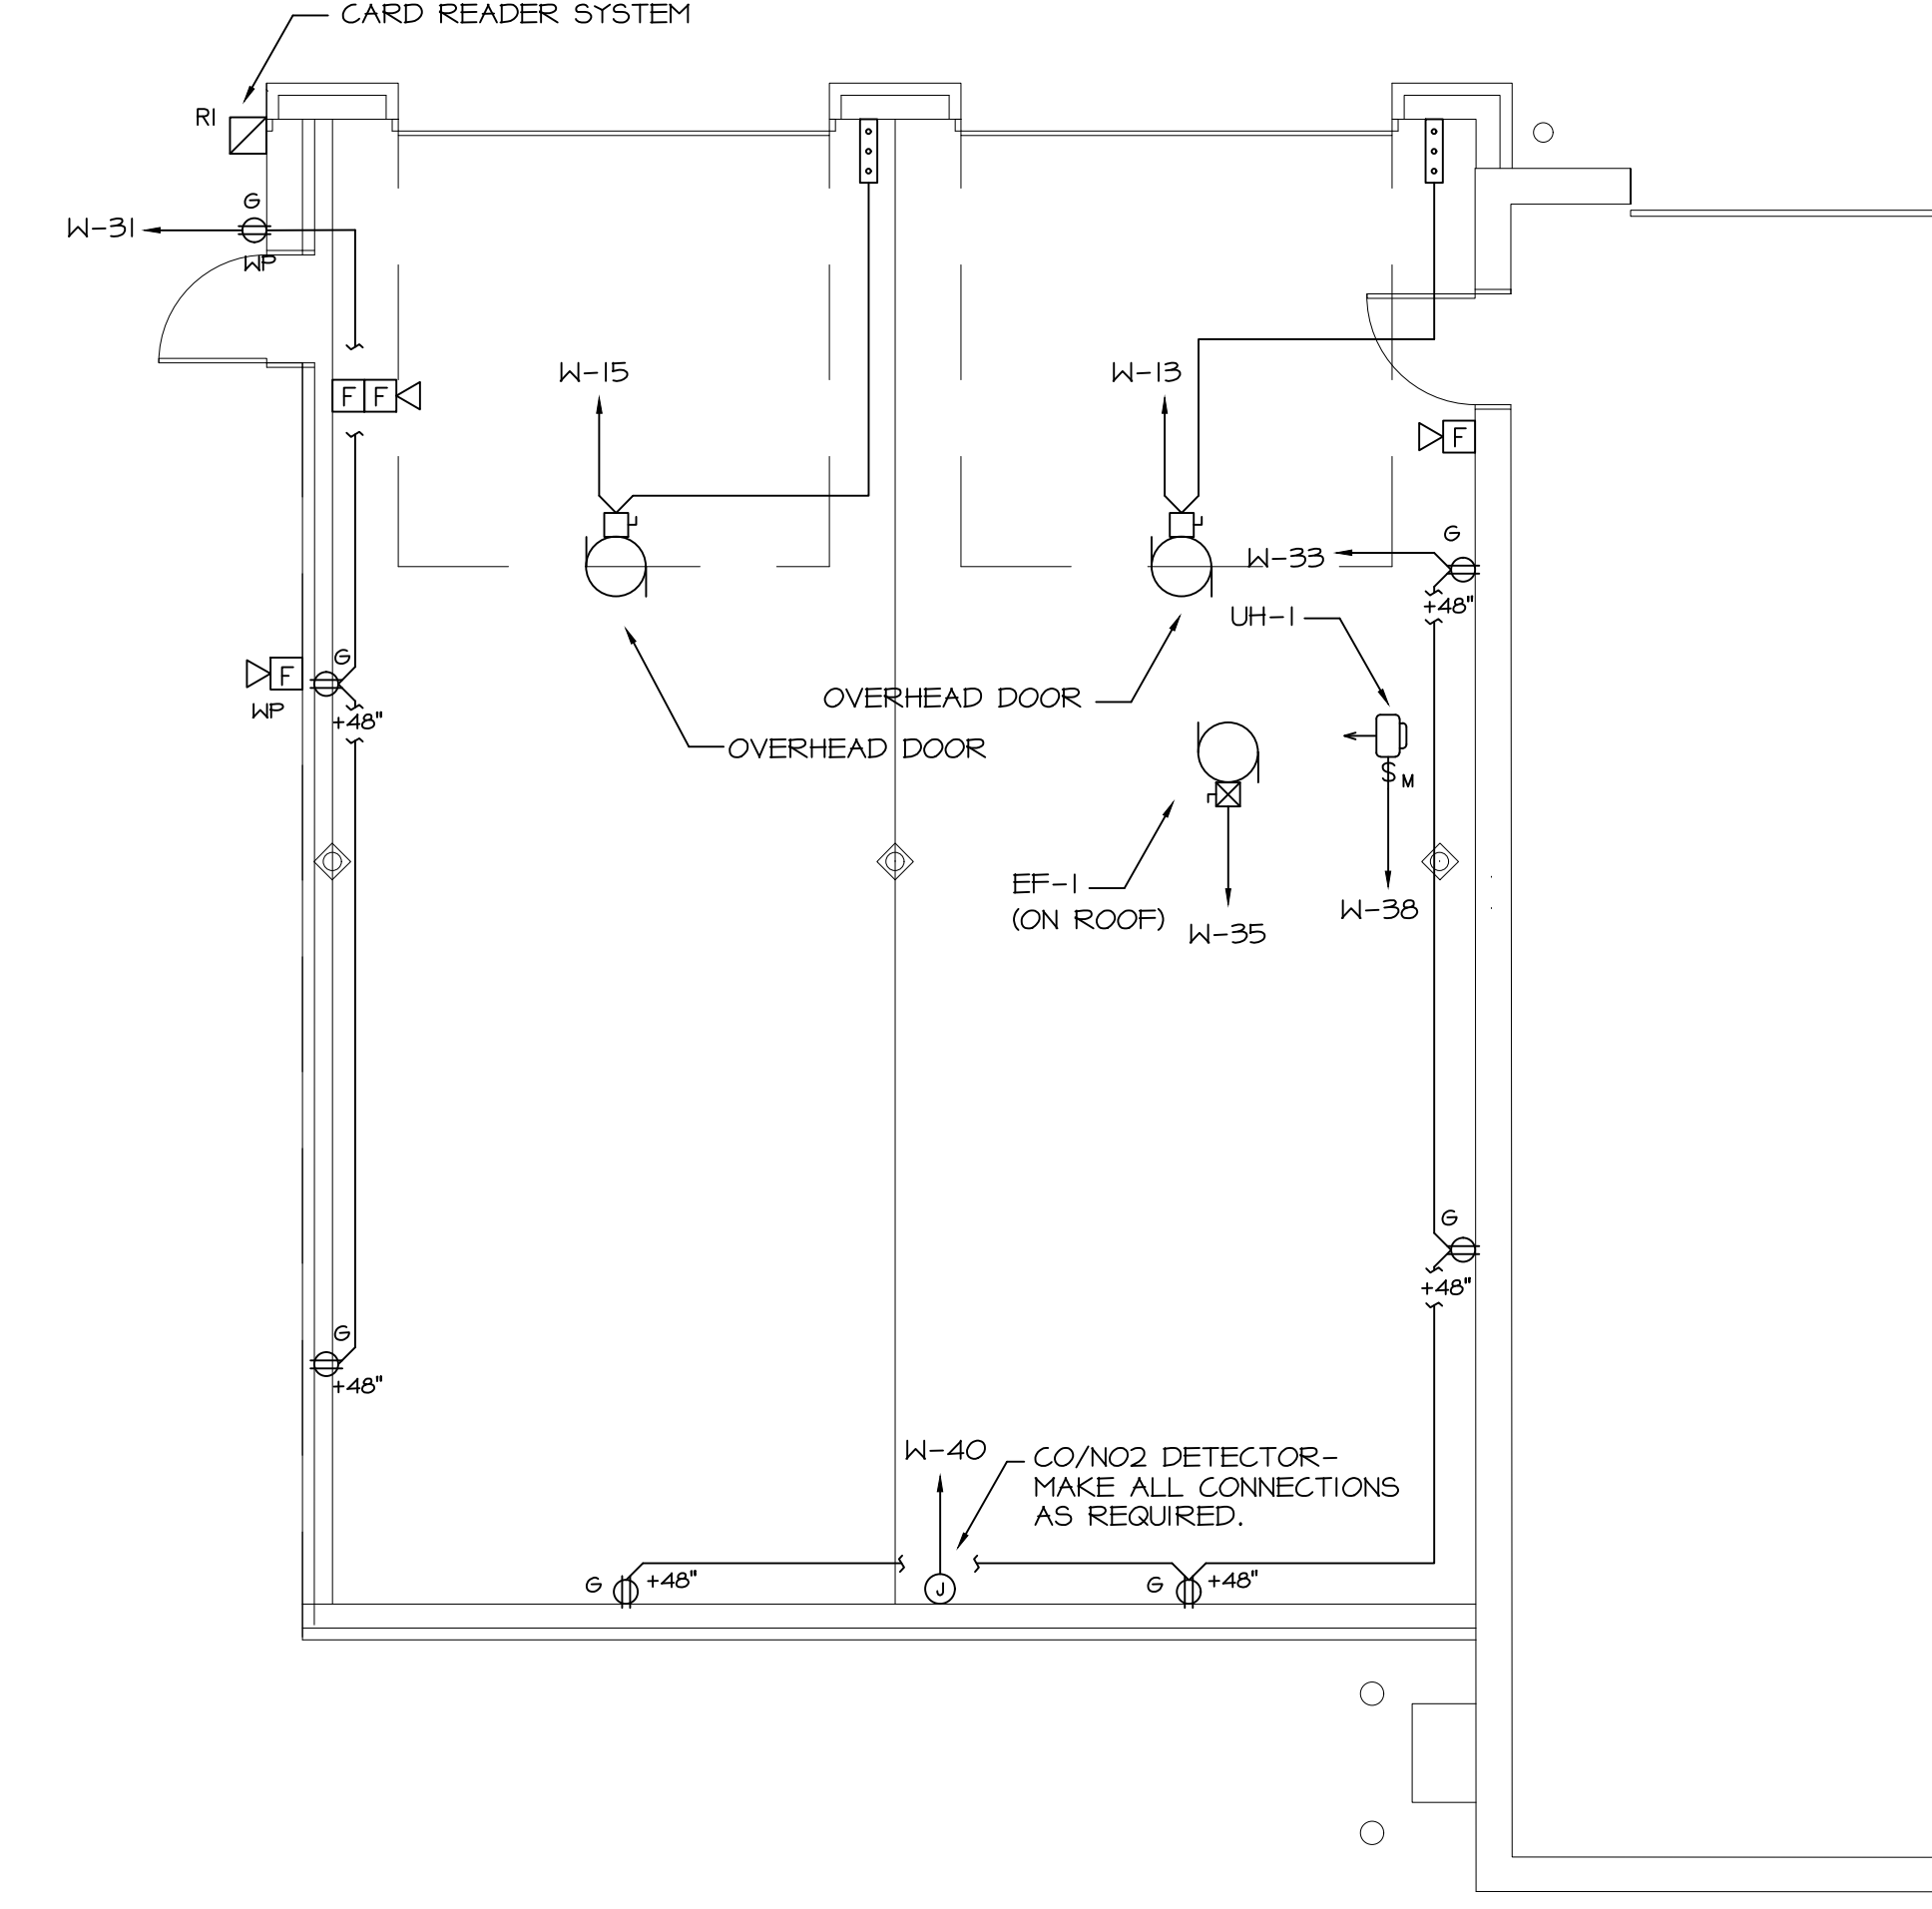

**FLOOR PLAN - POWER AND SYSTEMS ALT #1 ADDITION**  
 SCALE: 3/16"=1'-0"

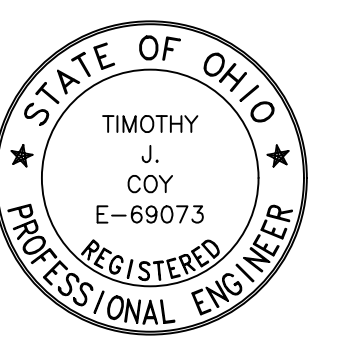

**NEWPORT LIBRARY GARAGE ADDITION**

YOUNGSTOWN, OHIO

NEWPORT BRANCH LIBRARY


**J.M. VEROSTKO, INC.**  
 CONSULTING ENGINEERS  
 2781 SALT SPRINGS ROAD    PHONE: (330) 799-1339  
 YOUNGSTOWN, OHIO 44509    URL: JMVROSTKO.COM

**FANIRO ARCHITECTS, INC.**

217 1/2 WEST FEDERAL STREET    YOUNGSTOWN, OHIO 44503

PHONE: 330 747 2800  
 FACSIMILE: 330 747 2802

SHEET NO. **E-3**    DATE    30 SEPT. 2019

PROJ. NO. 1913    REV.

